


GENERAL NOTES

1.) THE CONNECTION DIAGRAM SHOWN ON THIS SHEET IS A RECOMMENDATION ONLY. THE FINAL SYSTEM CONFIGURATION SHALL BE DETERMINED BY THE ELECTRICIAN INSTALLING THE SOLAR POWER SYSTEM.

3.) ALL WIRING AND MATERIALS REQUIRED TO INTERCONNECT ITEMS PROVIDED BY SOLARSET SHALL BE SUPPLIED AND INSTALLED BY THE END USER OR THEIR CONTRACTOR (OTHERS).

5.) ALL SOLAR MODULE FRAMES ARE BONDED USING ILSCO SGB-4 SOLAR BOND CLAMPS AND A CONTINUOUS 8 AWG BARE SOLID COPPER WIRE. A LOOSE COIL OF WIRE, EIGHT FEET IN LENGTH, IS PROVIDED AFTER THE LAST SOLAR MODULE BOND CLAMP. IT IS THE RESPONSIBILITY OF THE ELECTRICIAN INSTALLING THE SOLAR POWER SYSTEM TO CONNECT THE SOLAR MODULE BONDING WIRE TO A GROUND ROD. ALL BONDING CLAMPS ARE INSTALLED ON CLEAN BARE METAL USING OX-GARD ANTI-OXIDANT COMPOUND (DEL CITY PART NUMBER 964DL).

SOLARSET, 8 MODULE SKID, CHALLENGER

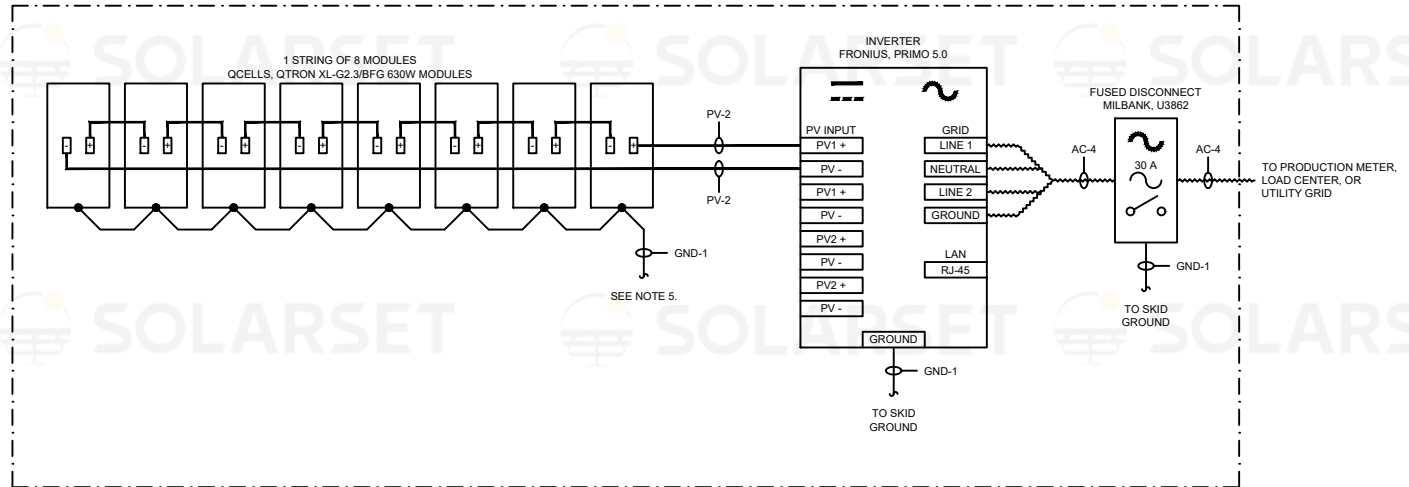

PROPRIETARY AND CONFIDENTIAL -- THE INFORMATION CONTAINED IN THIS DRAWING IS THE SOLE PROPERTY OF SOLARSE. ANY REPRODUCTION IN PART OR AS A WHOLE WITHOUT THE WRITTEN PERMISSION OF SOLARSE IS PROHIBITED.

DRAWING TITLE		 SOLARSET www.solarset.com 46920 County Road E Centex, CO 81126 719-754-5100 SOLARSET.COM											
GRID TIE SOLAR SYSTEM 008-4-GTP ONE LINE DIAGRAM		8											
		9											
		10											
		11											
		66											
WORK ORDER													
CUSTOMER													
DRAWING													
NO.													
DATE													
BY													
CHECKED													
APPROVED													
SCALE													
SHEET NO.													
TOTAL SHEETS													
PROJECT NO.													
CLIENT													
ADDRESS													
CITY													
STATE													
ZIP													
PHONE													
FAX													
EMAIL													
WEBSITE													
PROJECT NAME													
PROJECT LOCATION													
PROJECT DESCRIPTION													
PROJECT START DATE													
PROJECT END DATE													
PROJECT BUDGET													
PROJECT STATUS													
PROJECT OWNER													
PROJECT MANAGER													
PROJECT ENGINEER													
PROJECT ARCHITECT													
PROJECT CONTRACTOR													
PROJECT SUBMITTER													
PROJECT REVIEWER													
PROJECT APPROVER													
PROJECT SIGNED													
PROJECT DATED													
PROJECT SCALE													
PROJECT SHEET NO.													
PROJECT TOTAL SHEETS													
PROJECT PROJECT NO.													
PROJECT CLIENT													
PROJECT ADDRESS													
PROJECT CITY													
PROJECT STATE													
PROJECT ZIP													
PROJECT PHONE													
PROJECT FAX													
PROJECT EMAIL													
PROJECT WEBSITE													
PROJECT PROJECT NAME													
PROJECT PROJECT LOCATION													
PROJECT PROJECT DESCRIPTION													
PROJECT PROJECT START DATE													
PROJECT PROJECT END DATE													
PROJECT PROJECT BUDGET													
PROJECT PROJECT STATUS													
PROJECT PROJECT OWNER													
PROJECT PROJECT MANAGER													
PROJECT PROJECT ENGINEER													
PROJECT PROJECT ARCHITECT													
PROJECT PROJECT CONTRACTOR													
PROJECT PROJECT SUBMITTER													
PROJECT PROJECT REVIEWER													
PROJECT PROJECT APPROVER													
PROJECT PROJECT SIGNED													
PROJECT PROJECT DATED													
PROJECT PROJECT SCALE													
PROJECT PROJECT SHEET NO.													
PROJECT PROJECT TOTAL SHEETS													
PROJECT PROJECT PROJECT NO.													
PROJECT PROJECT CLIENT													
PROJECT PROJECT ADDRESS													
PROJECT PROJECT CITY													
PROJECT PROJECT STATE													
PROJECT PROJECT ZIP													
PROJECT PROJECT PHONE													
PROJECT PROJECT FAX													
PROJECT PROJECT EMAIL													
PROJECT PROJECT WEBSITE													
PROJECT PROJECT PROJECT NAME													
PROJECT PROJECT PROJECT LOCATION													
PROJECT PROJECT PROJECT DESCRIPTION													
PROJECT PROJECT PROJECT START DATE													
PROJECT PROJECT PROJECT END DATE													
PROJECT PROJECT PROJECT BUDGET													
PROJECT PROJECT PROJECT STATUS													
PROJECT PROJECT PROJECT OWNER													
PROJECT PROJECT PROJECT MANAGER													
PROJECT PROJECT PROJECT ENGINEER													
PROJECT PROJECT PROJECT ARCHITECT													
PROJECT PROJECT PROJECT CONTRACTOR													
PROJECT PROJECT PROJECT SUBMITTER													
PROJECT PROJECT PROJECT REVIEWER													
PROJECT PROJECT PROJECT APPROVER													
PROJECT PROJECT PROJECT SIGNED													
PROJECT PROJECT PROJECT DATED													
PROJECT PROJECT PROJECT SCALE													
PROJECT PROJECT PROJECT SHEET NO.													
PROJECT PROJECT PROJECT TOTAL SHEETS													
PROJECT PROJECT PROJECT PROJECT NO.													
PROJECT PROJECT PROJECT CLIENT													
PROJECT PROJECT PROJECT ADDRESS													
PROJECT PROJECT PROJECT CITY													
PROJECT PROJECT PROJECT STATE													
PROJECT PROJECT PROJECT ZIP													
PROJECT PROJECT PROJECT PHONE													
PROJECT PROJECT PROJECT FAX													
PROJECT PROJECT PROJECT EMAIL													
PROJECT PROJECT PROJECT WEBSITE													
PROJECT PROJECT PROJECT PROJECT NAME													
PROJECT PROJECT PROJECT PROJECT LOCATION													
PROJECT PROJECT PROJECT PROJECT DESCRIPTION													
PROJECT PROJECT PROJECT PROJECT START DATE													
PROJECT PROJECT PROJECT PROJECT END DATE													
PROJECT PROJECT PROJECT PROJECT BUDGET													
PROJECT PROJECT PROJECT PROJECT STATUS													
PROJECT PROJECT PROJECT PROJECT OWNER													
PROJECT PROJECT PROJECT PROJECT MANAGER													
PROJECT PROJECT PROJECT PROJECT ENGINEER													
PROJECT PROJECT PROJECT PROJECT ARCHITECT													
PROJECT PROJECT PROJECT PROJECT CONTRACTOR													
PROJECT PROJECT PROJECT PROJECT SUBMITTER													
PROJECT PROJECT PROJECT PROJECT REVIEWER													
PROJECT PROJECT PROJECT PROJECT APPROVER													
PROJECT PROJECT PROJECT PROJECT SIGNED													
PROJECT PROJECT PROJECT PROJECT DATED													
PROJECT PROJECT PROJECT PROJECT SCALE													
PROJECT PROJECT PROJECT PROJECT SHEET NO.													
PROJECT PROJECT PROJECT PROJECT TOTAL SHEETS													
PROJECT PROJECT PROJECT PROJECT PROJECT NO.													
PROJECT PROJECT PROJECT PROJECT CLIENT													
PROJECT PROJECT PROJECT PROJECT ADDRESS													
PROJECT PROJECT PROJECT PROJECT CITY													